


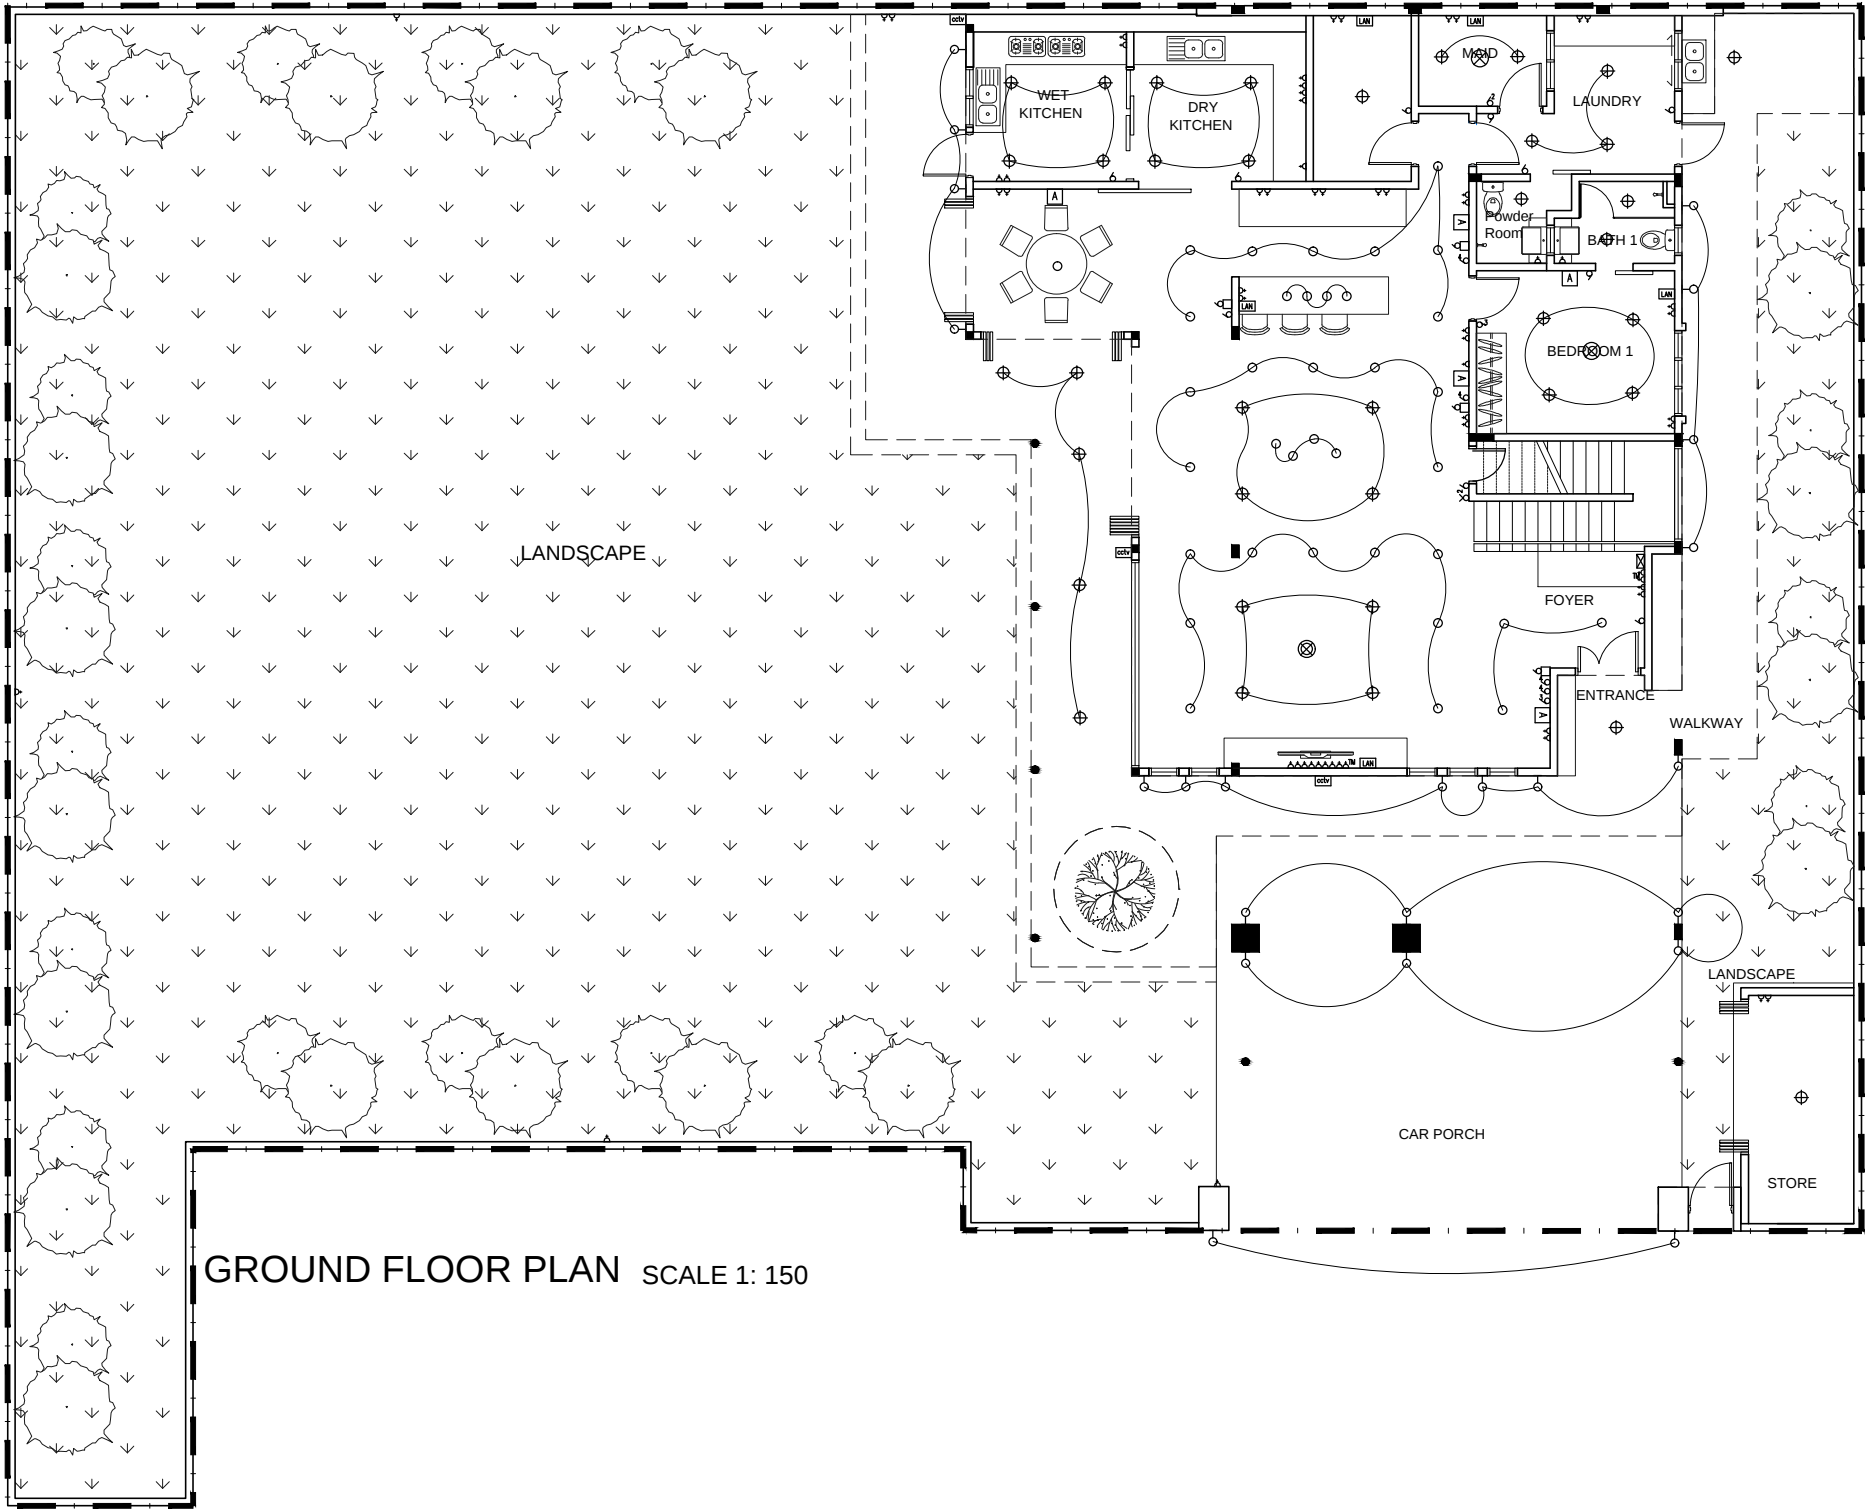

GROUND FLOOR PLAN SCALE 1: 150

LEGEND – ELECTRICAL	
SYMBOL	DESCRIPTION
	DOWNLIGHT POINT
	LIGHTING/EYEBALL POINT
	AIRCOND POINT
	FUSE BOX
	CEILING FAN POINT
	WALL MOUNTED POINT
	5A ONE WAY SWITCH
	5A TWO WAY SWITCH
	13A SOCKET OUTLET
	AIRCOND SWITCH
	LAN POINT
	CCTV POINT

NOTES:
THIS DRAWING IS FOR DESIGN PURPOSED ONLY
CONTRACTOR IS PROHIBITED TO USE THIS DRAWING
FOR CONSTRUCTION.

DESIGN DRAWING

OWNER :
CHUAH SU CHOON -
28 Residency, 10 Jalan PJU 3/28H,
Sunway Damansara, Selangor Darul Ehsan.

TEL : +6017-333 8829 FAX : -

DESIGNER :

maad

MAA DESIGN (SA0350876-P)
93, JALAN USJ 18 /1
47630 Subang Jaya, Selangor Darul Ehsan ,Malaysia. Tel: 012-2829 036

PROJECT :
PROPOSED EXTENSION FOR DOUBLE STOREY
BUNGALOW UNIT


REV	DATE	AMENDMENTS

DRAWING TITLE :
NEW GROUND FLOOR PLAN ELECTRICAL DRAWING

SCALE	: 1 : 150	DATE	: JUNE 2016
DRAWN BY	: LM	CHECKED BY	: TS
PARTNER I.C	: -	PROJ. DESIGNER	: SHYUAN

MAAD05/1004/01A

REVISION
(A)

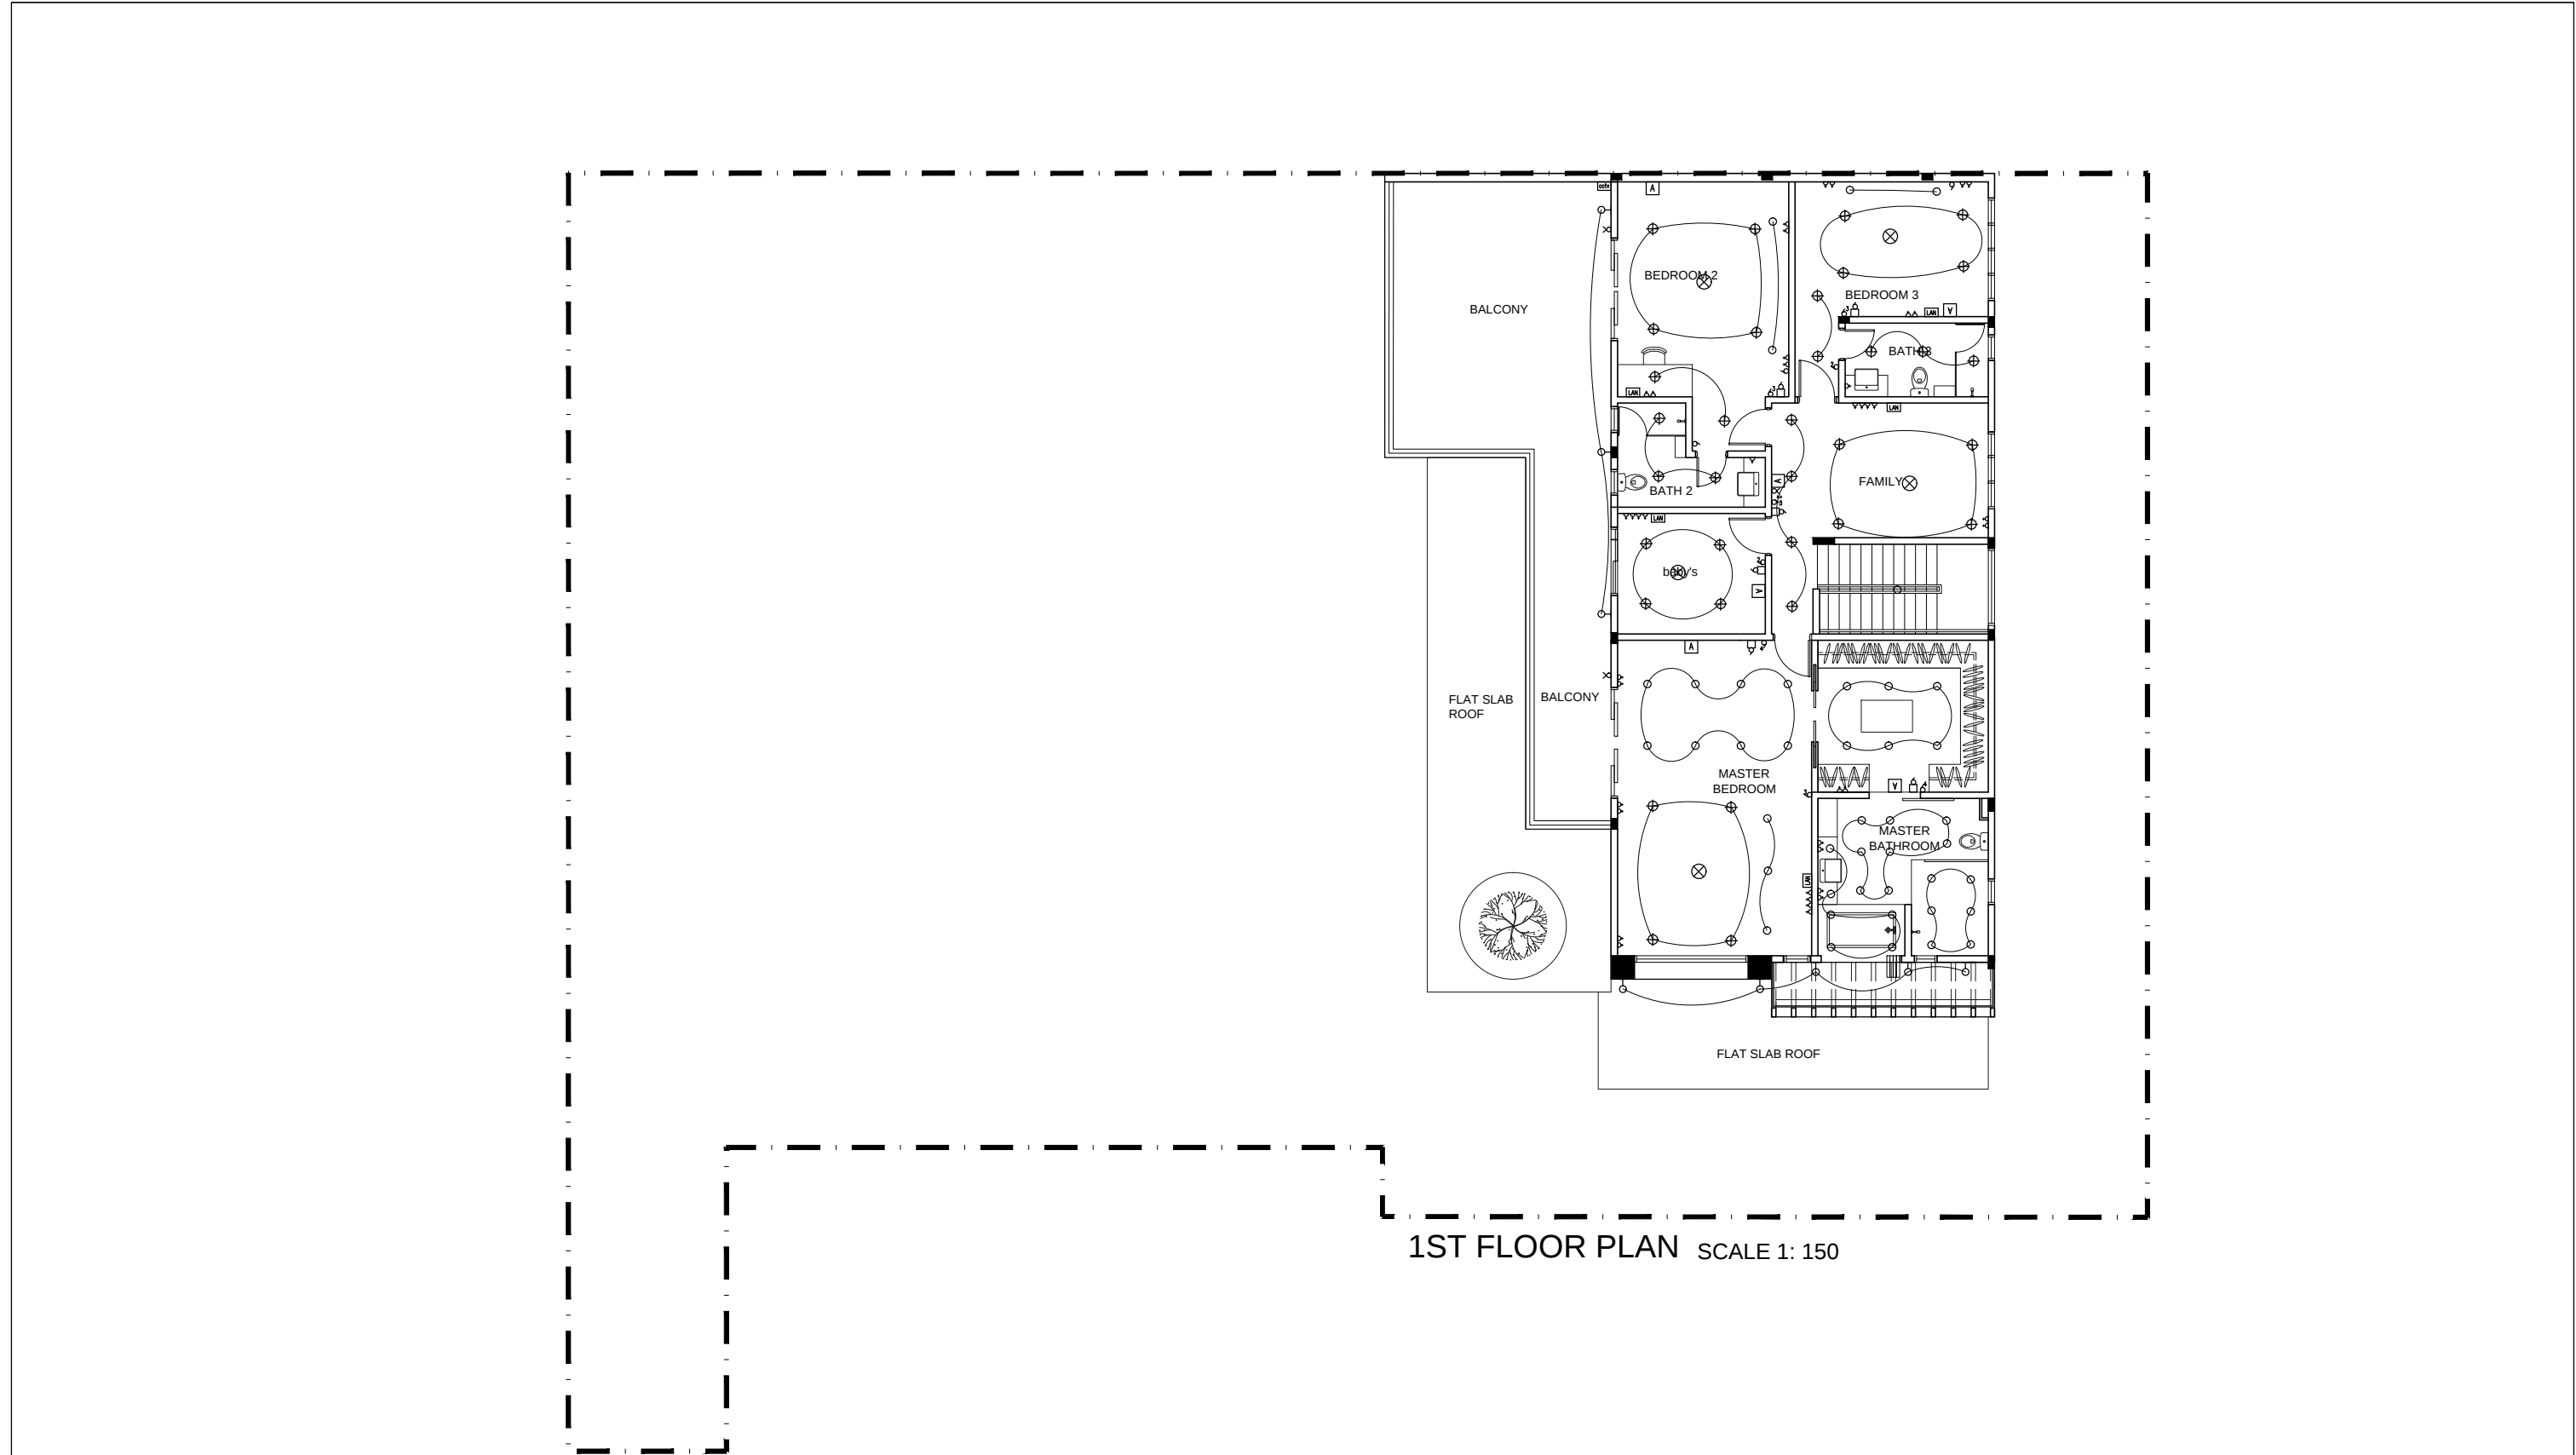

1ST FLOOR PLAN SCALE 1: 150

NOTES:
THIS DRAWING IS FOR DESIGN PURPOSED ONLY
CONTRACTOR IS PROHIBITED TO USE THIS DRAWING
FOR CONSTRUCTION.

DESIGN DRAWING

OWNER :
CHUAH SU CHOON -
28 Residency, 10 Jalan PJU 3/28H,
Sunway Damansara, Selangor Darul Ehsan.

TEL : +6017-333 8829 FAX : -

DESIGNER :

maad

MAA DESIGN (SA0350876-P)
93, JALAN USJ 18 /1
47630 Subang Jaya, Selangor Darul Ehsan ,Malaysia. Tel: 012-2829 036

PROJECT :
PROPOSED EXTENSION FOR DOUBLE STOREY
BUNGALOW UNIT

REV	DATE	AMENDMENTS

DRAWING TITLE :
NEW 1ST FLOOR PLAN ELECTRICAL DRAWING

SCALE	: 1 : 150	DATE	: JUNE 2016
DRAWN BY	: LM	CHECKED BY	: TS
PARTNER LC	: -	PROJ. DESIGNER	: SHYUAN

MAAD05/1004/02A

REVISION
(A)