



**HABITUS APARTMENT
LAYOUT PLAN
SCALE 1 : 50 (A3)
586 sqft.**

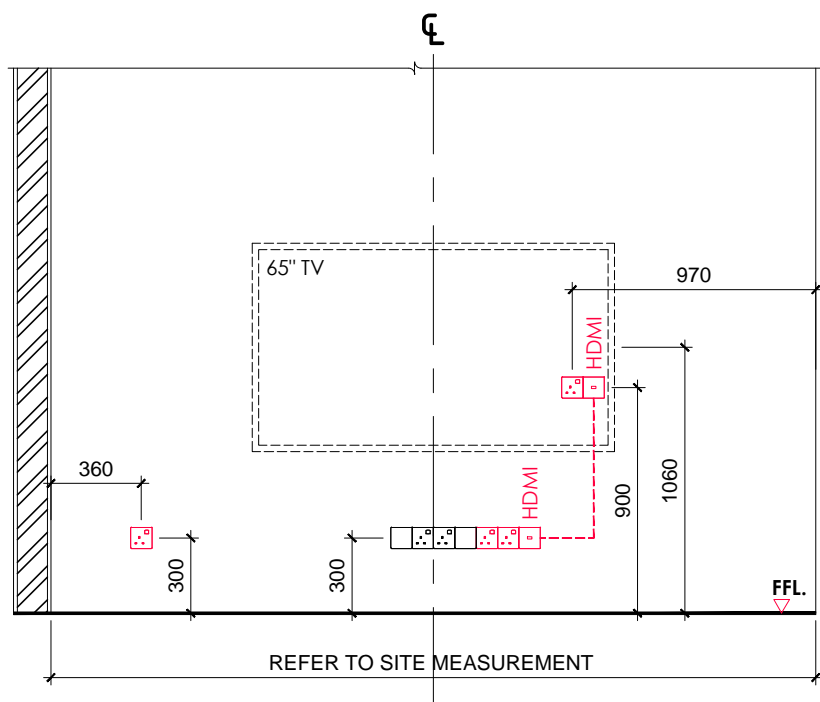


**ELEVATION OF LIVING AREA
SCALE 1 : 30**

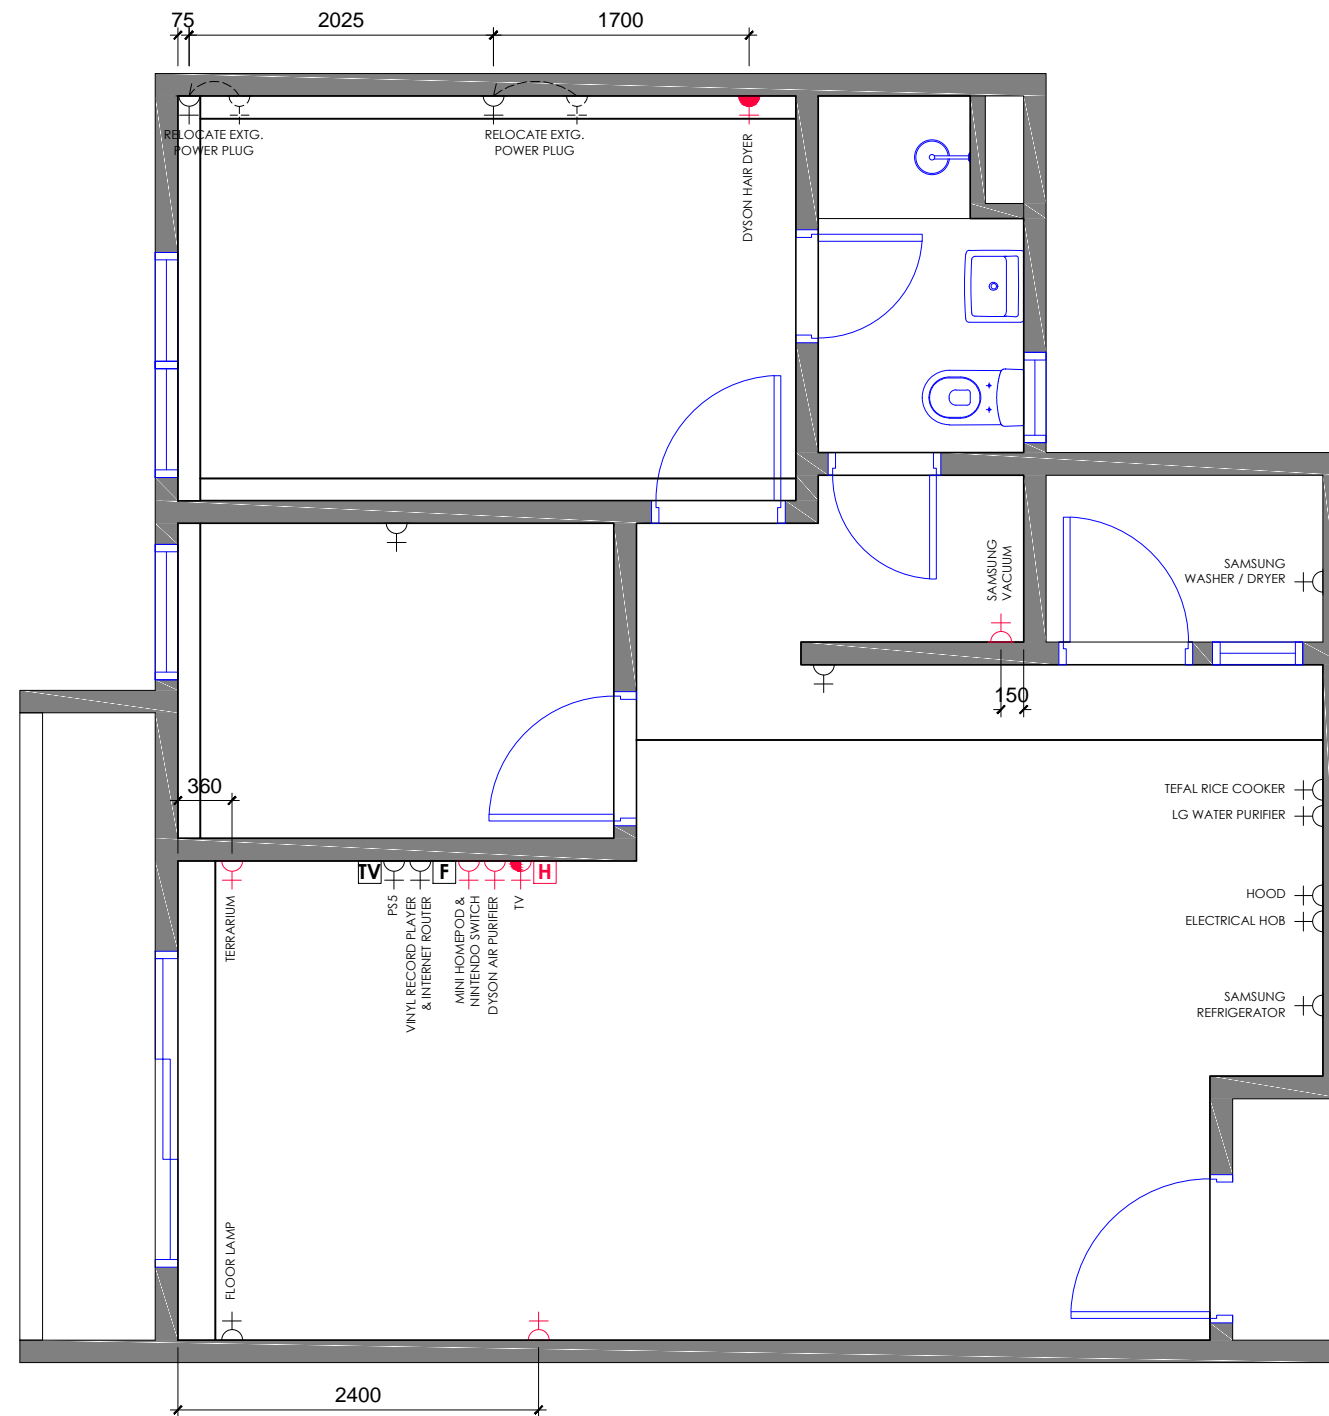


**HABITUS APARTMENT
ELECTRICAL LAYOUT PLAN
SCALE 1 : 50 (A3)
586 sqft.**

SYMBOL	DESCRIPTION	QUANTITY
	NEW POWER POINT OUTLET @ 300mm HT.	5 NOS
	NEW POWER POINT OUTLET @ 900mm HT.	1 NO
	NEW POWER POINT OUTLET @ 1200mm HT.	1 NO
	EXISTING POWER POINT OUTLET @ 300mm HT.	13 NOS
	NEW HDMI POINT @ 300mm & 900mm HT.	1 SET

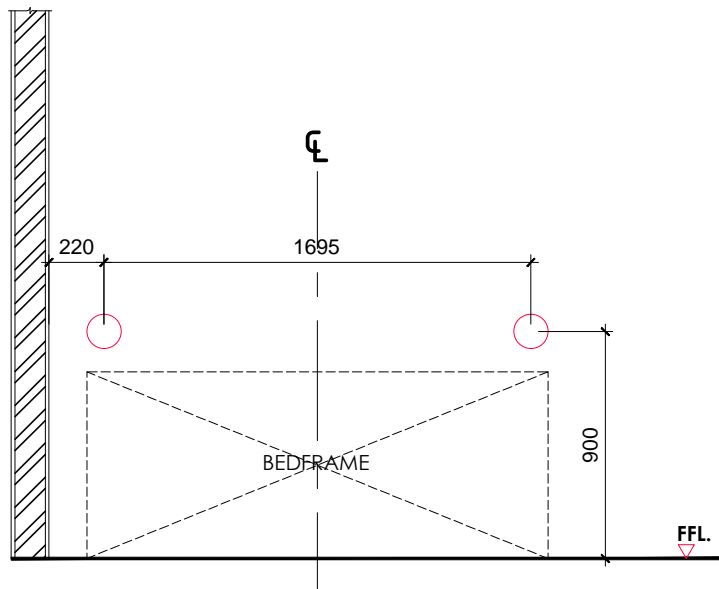
 


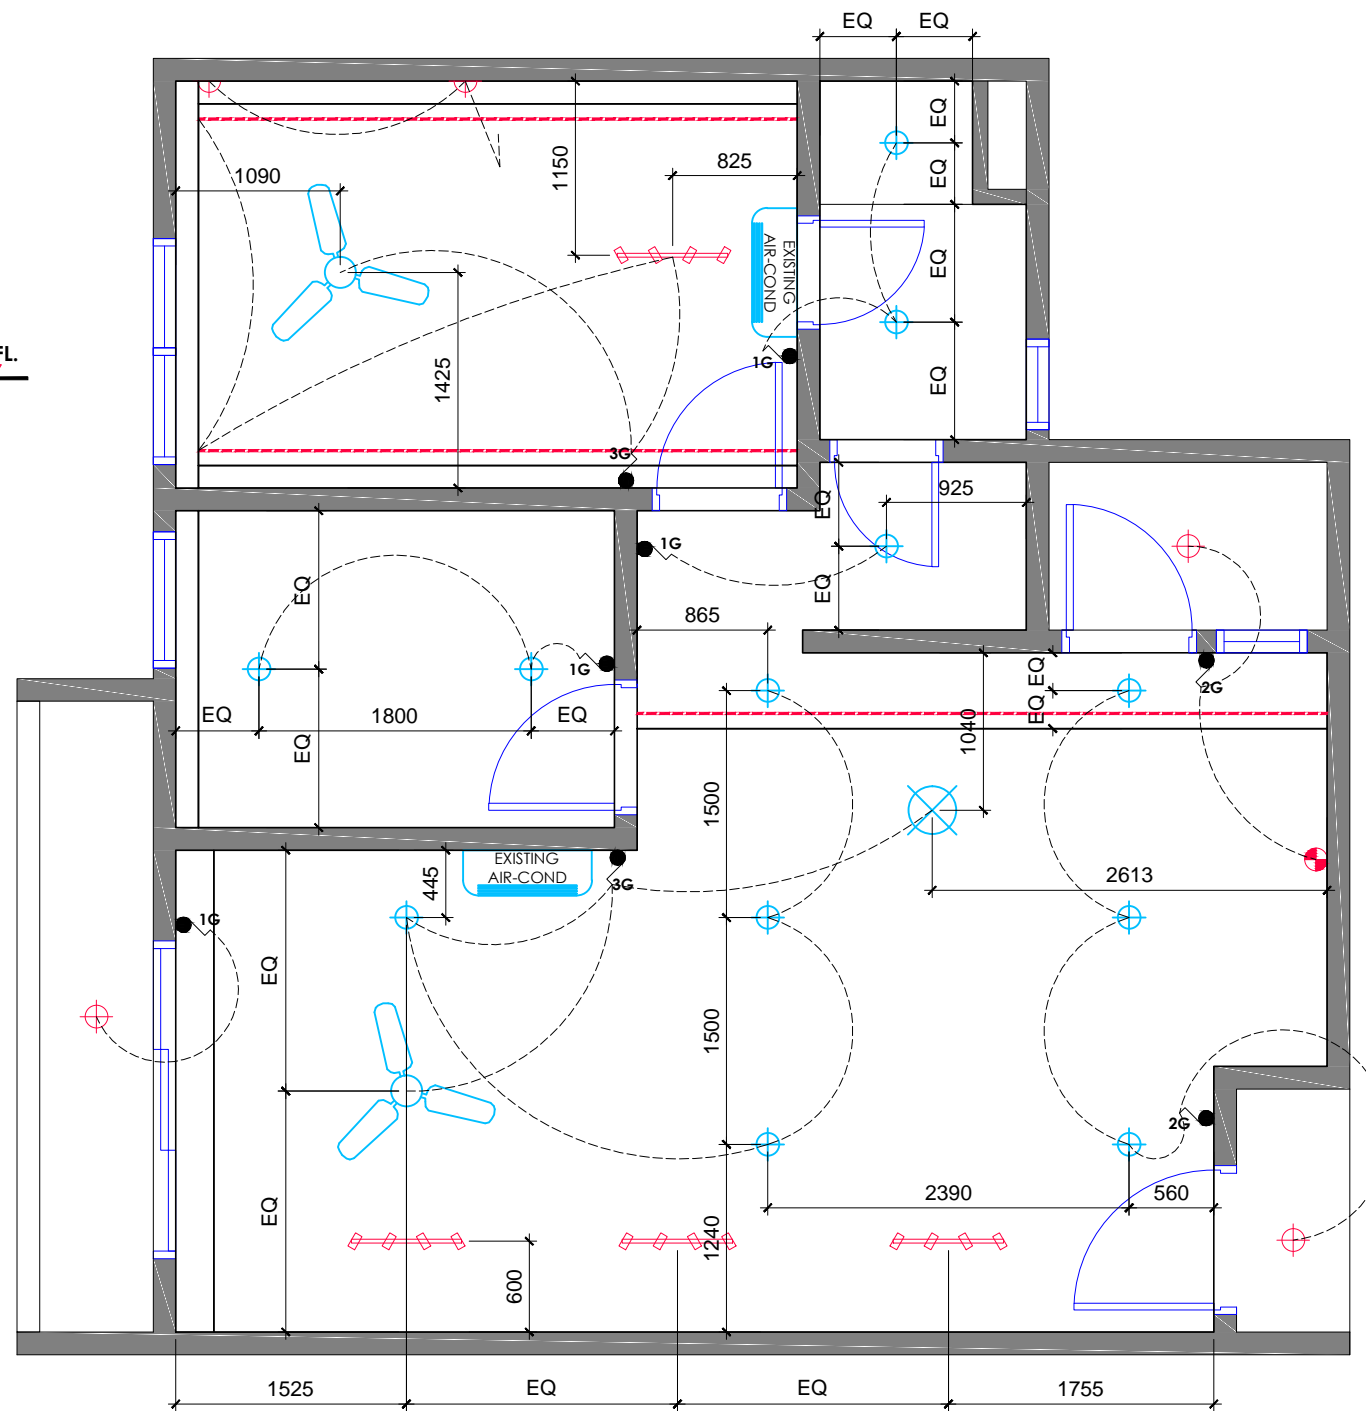


DETAIL OF WALL LIGHT @ MASTER BEDROOM
SCALE 1 : 30




HABITUS APARTMENT
REFLECTED CEILING PLAN
SCALE 1 : 50 (A3)
586 sqft.

SYMBOL	DESCRIPTION	QUANTITY
	LED RECESSED EYEBALL LIGHT (INSTALLATION ONLY)	12 NOS
	SURFACED MOUNTED CEILING LIGHT (INSTALLATION ONLY)	3 NOS
	PENDANT LIGHT (INSTALLATION ONLY)	1 NO
	WALL LIGHT (INSTALLATION ONLY)	2 NOS
	SURFACED MOUNTED TRACK LIGHT (INSTALLATION ONLY)	4 NOS
	90° ALUM. CHANNEL C/W COB LED STRIP IN 3000K	13 MR
	PROVISION POINT	1 NO
	CEILING MOUNTED FAN (INSTALLATION ONLY)	2 NOS
	1 GANG WALL SWITCH	4 NOS
	2 GANG WALL SWITCH	2 NOS
	3 GANG WALL SWITCH	2 NOS


SYMBOL	DESCRIPTION
	PLASTER CEILING IN WHITE EMULSION PAINT FINISH
	EXISTING PLASTER CEILING IN WHITE EMULSION PAINT FINISH
	PELMET CEILING FOR CURTAIN RAIL (REFER TO DETAIL DRAWING)
	COVE CEILING (REFER TO DETAIL DRAWINGS)

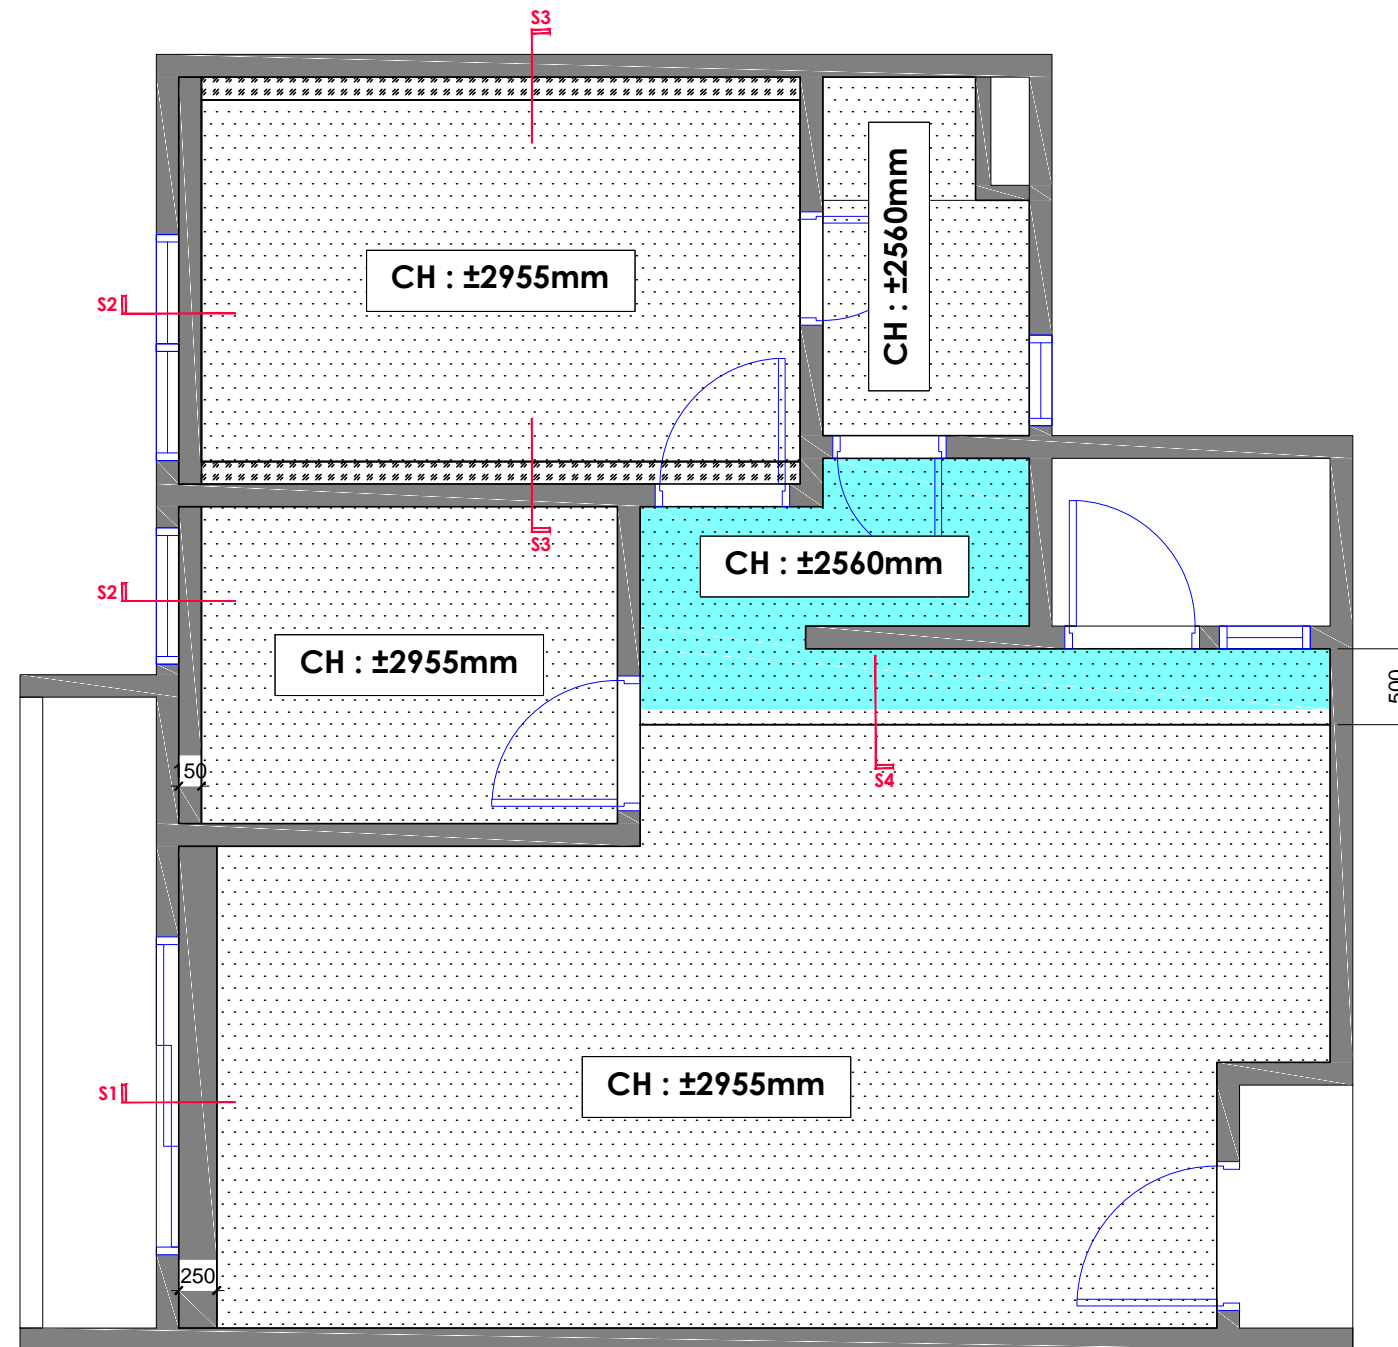

HABITUS APARTMENT
 CEILING FINISHES LAYOUT PLAN
 SCALE 1 : 50 (A3)
 586 sqft.

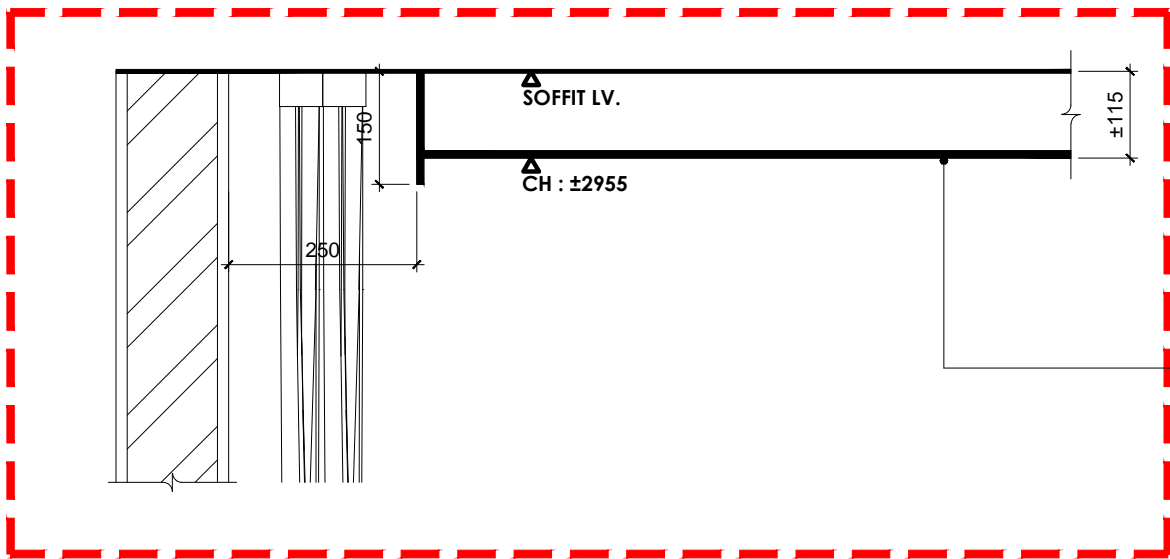


CEILING DETAIL SECTION S1
SCALE 1:10

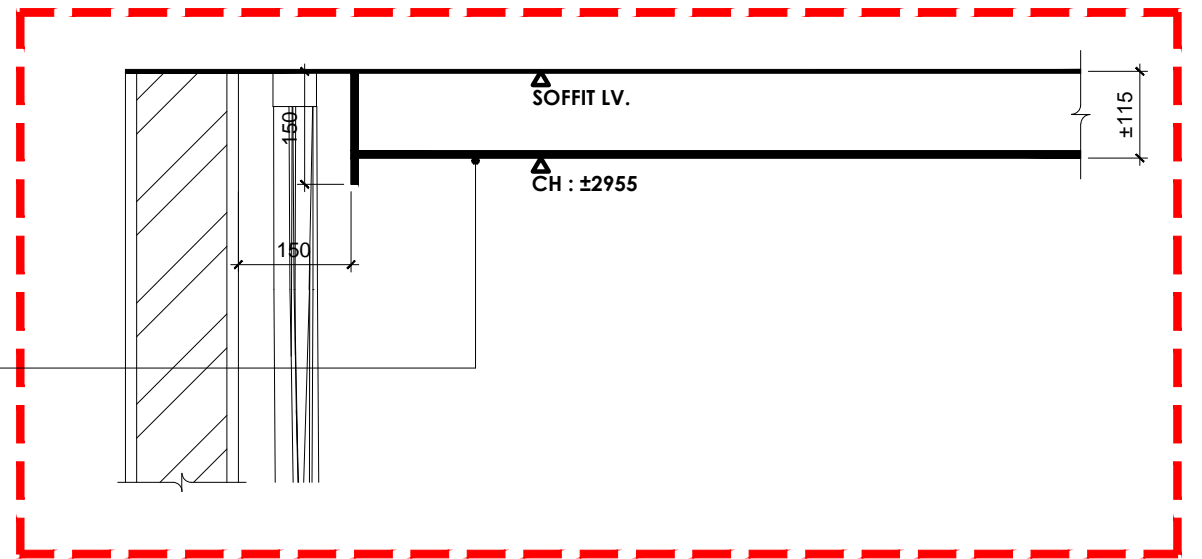

CEILING DETAIL SECTION S2
SCALE 1:10

PLASTER CEILING IN SEL.
EMULSION PAINT FINISH

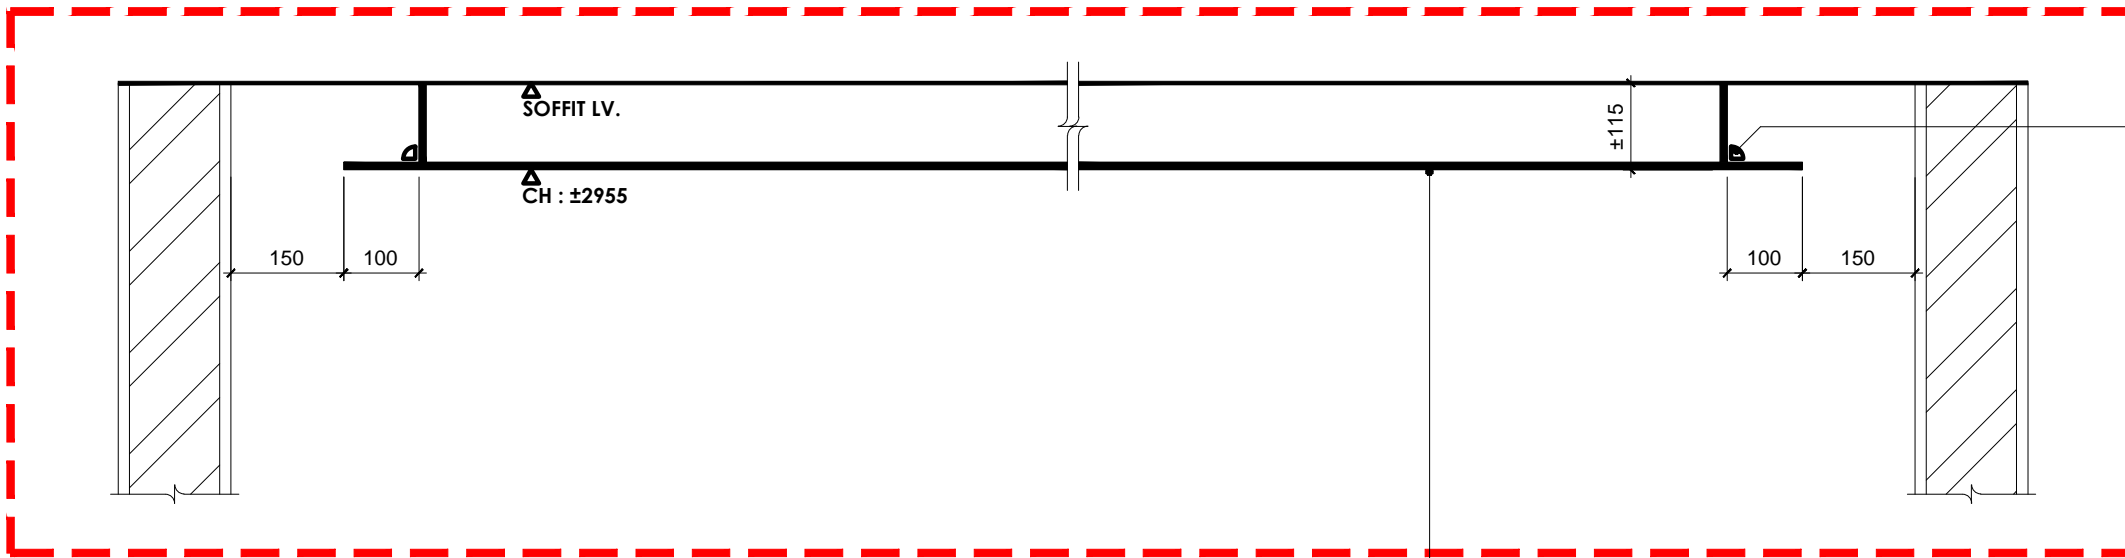


CEILING DETAIL SECTION S3
SCALE 1:10

90° ALUM. CHANNEL C/W
COB LED STRIP IN 3000K



PLASTER CEILING IN SEL.
EMULSION PAINT FINISH

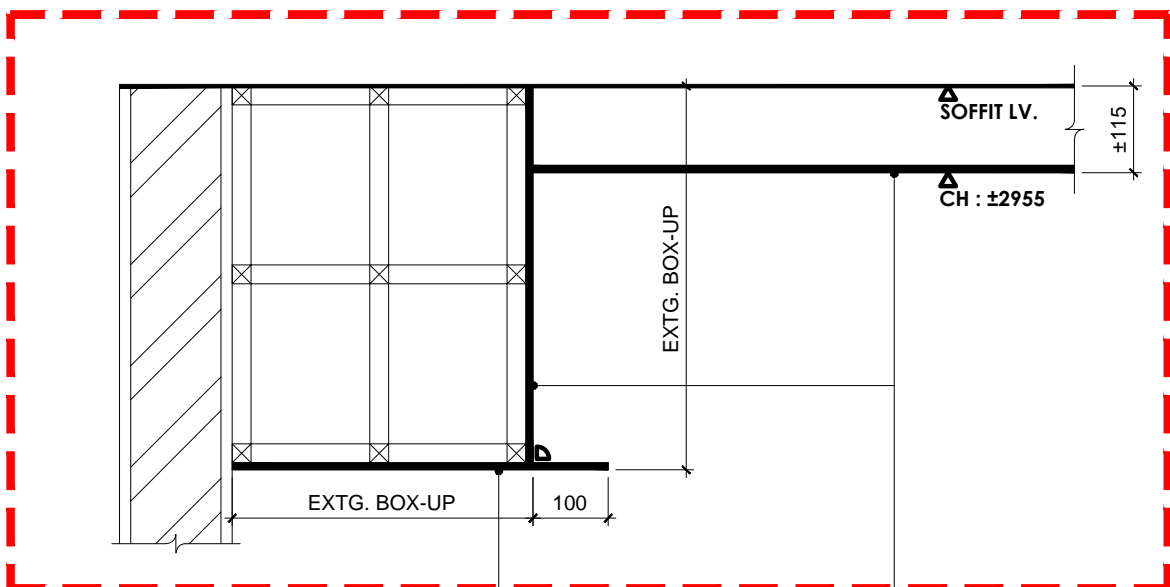

CEILING DETAIL SECTION S3
SCALE 1:10

PLASTER CEILING IN SEL.
EMULSION PAINT FINISH