
 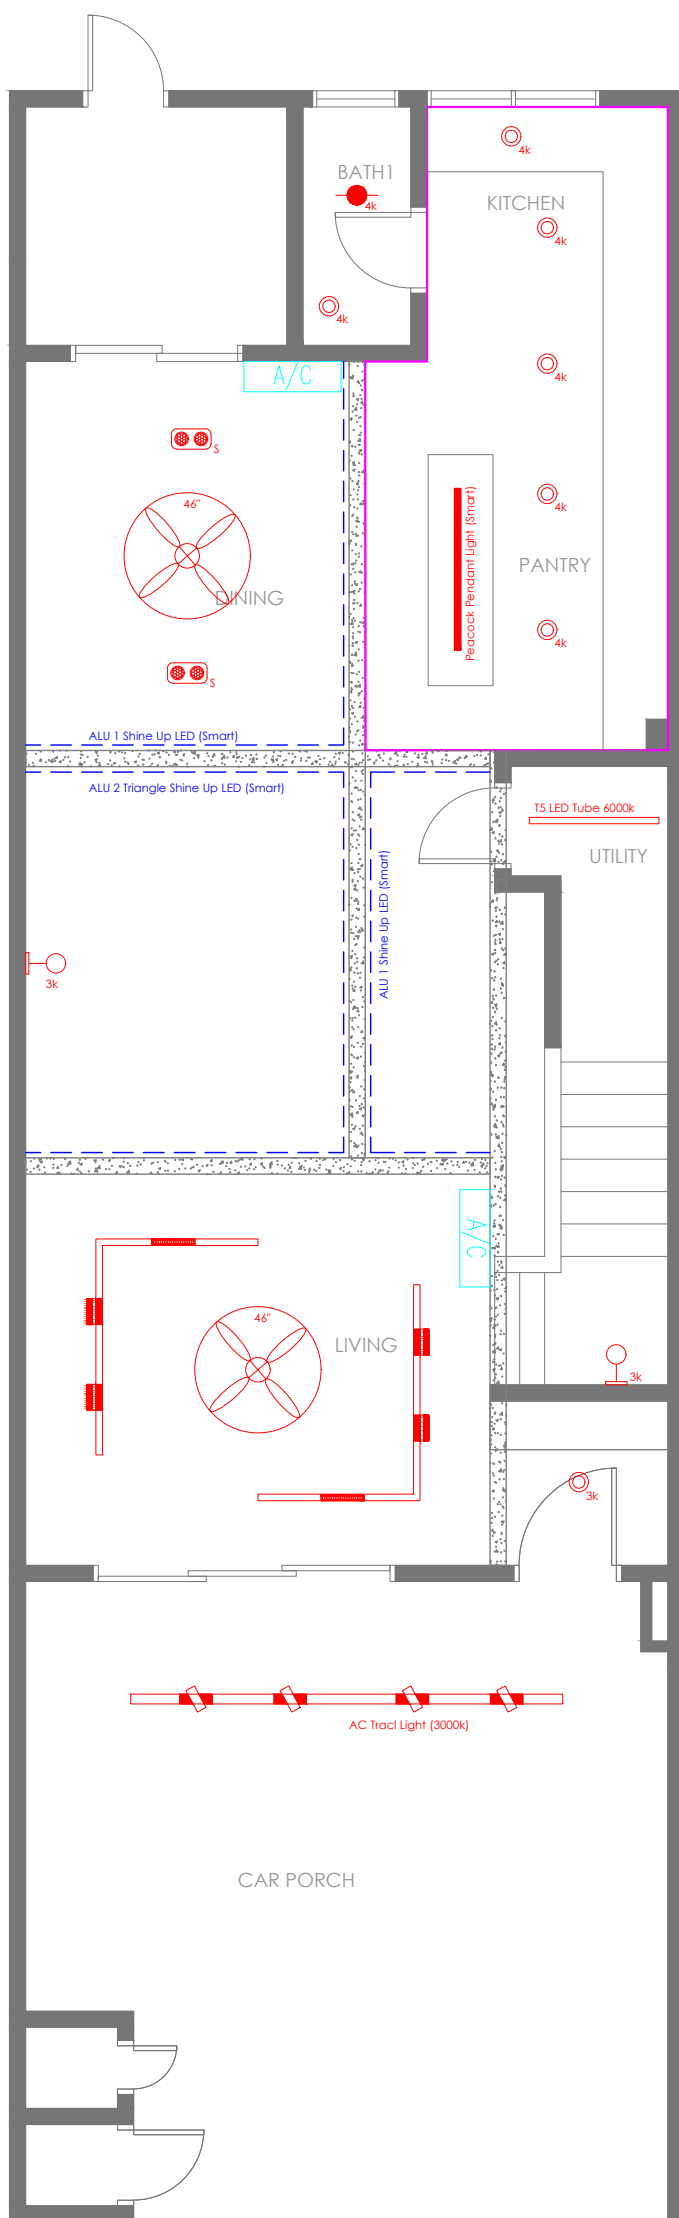


GF



Legend Of Drawing List	
Symbol	Description
	Recessed Anti Glaring Eyeball (3000k)
	Recessed Anti Glaring Eyeball (4000k)
	Recessed Downlight 6" (4000k)
	Surface Mounted Double Head Eyeball (Smart)
	T5 LED Tube (6000k)
	Selected Wall Light (3000k)
	Surface Mounted AC Track (3000k)
	Peacock Pendant Light (Smart)
	Recessed Magnetic Track Light (Smart)
	Smart LED Strip
	New Ceiling Guideline


001

LIGHTING PLAN

SCALE 1:70

PROJECT TITLE : PROPOSED LIGHTING PLAN FOR MR. ZHAFRAN'S HOUSE	DATE :	AMENDMENT DATE :	APPROVED BY CLIENT : <
---	--------	------------------	---

1 F

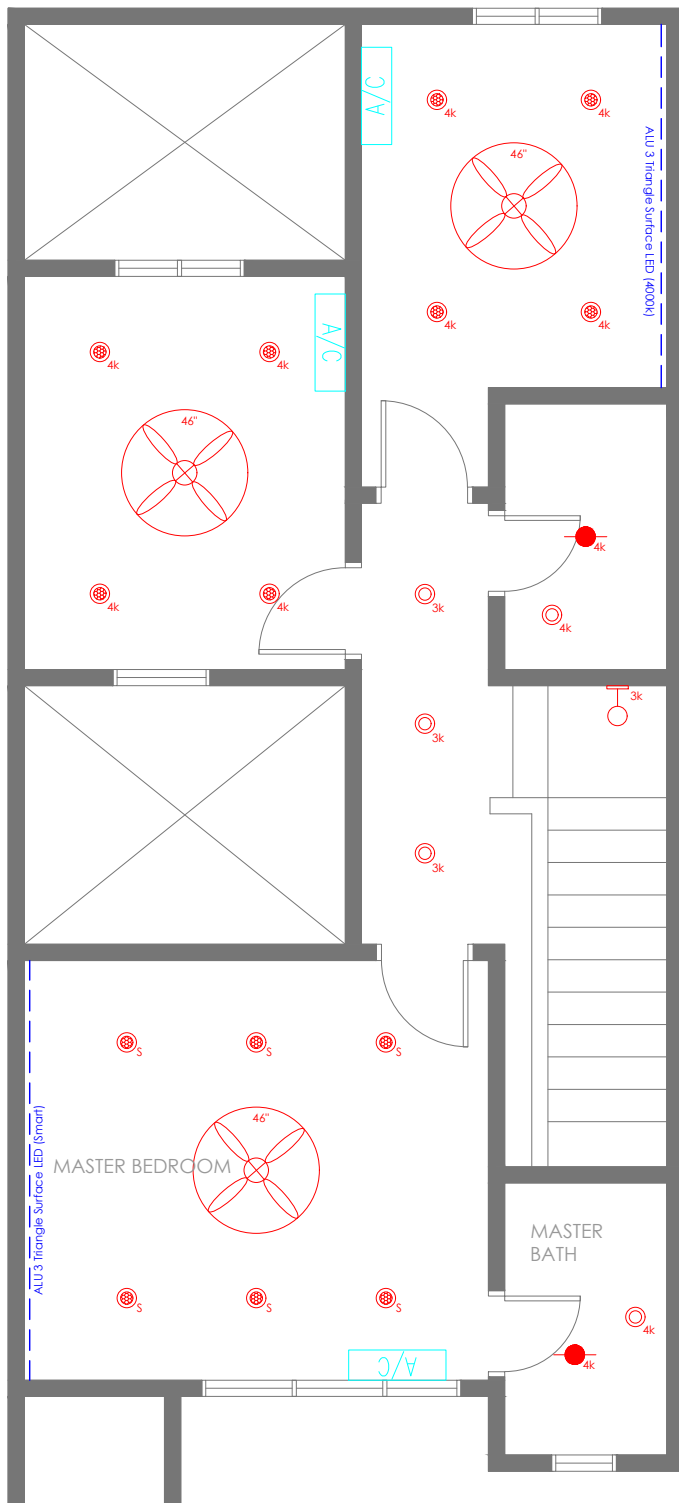

Legend Of Drawing List	
Symbol	Description
	Recessed Anti Glaring Eyeball (3000k)
	Recessed Anti Glaring Eyeball (4000k)
	Recessed Anti Glaring Adjustable Eyeball (4000k)
	Recessed Anti Glaring Adjustable Eyeball (4000k)
	Recessed Downlight 6" (4000k)
	Selected Wall Light (3000k)
	4000k LED Strip
	Smart LED Strip

001

LIGHTING PLAN

SCALE 1:70

[illegible]